


THE INFORMATION CONTAINED IN THIS DRAWING IS THE SOLE PROPERTY OF L-COM, INC. ANY REPRODUCTION IN PART OR WHOLE WITHOUT THE WRITTEN PERMISSION OF L-COM, INC. IS PROHIBITED.

REVISIONS			
REV	DESCRIPTION	DATE	APPROVED
A	INITIAL RELEASE	04/28/17	J.LABOY
B	ECN 8743: CHANGE PACKAGING SPEC FROM PKG-00012 TO PS-0031	05/01/17	J.LABOY

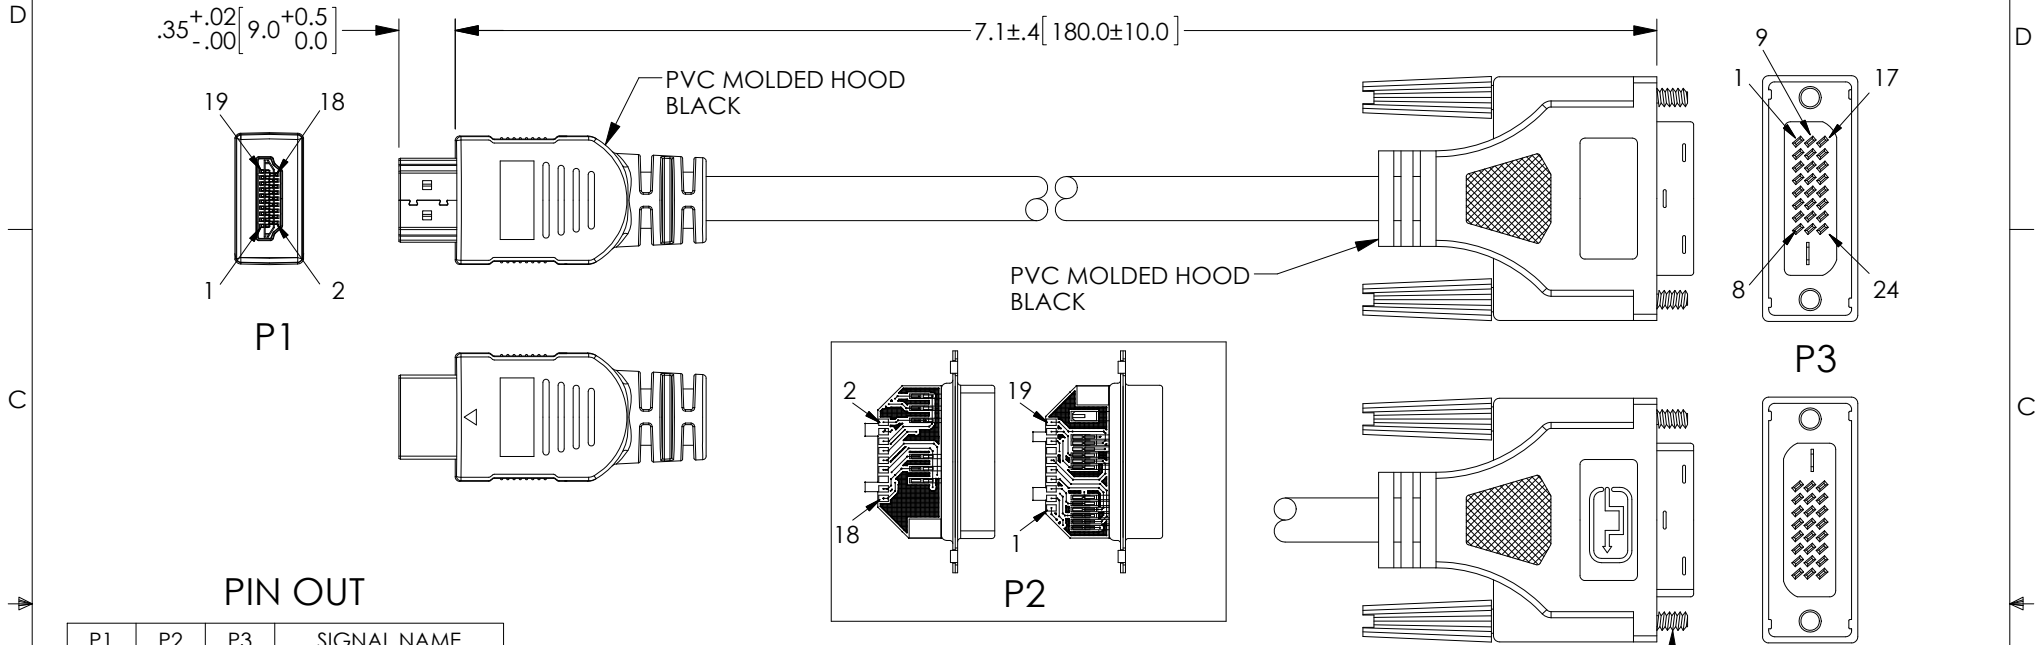

PIN OUT

P1	P2	P3	SIGNAL NAME
1	1	2	TMDS Data2+
3	3	1	TMDS Data2-
5	5	3	TMDS Data2 SHIELD
4	4	10	TMDS Data1+
6	6	9	TMDS Data1-
2	2	11	TMDS Data1 SHIELD
7	7	18	TMDS Data0+
9	9	17	TMDS Data0-
11	11	19	TMDS Data0 SHIELD
10	10	23	TMDS CLOCK+
12	12	24	TMDS CLOCK-
8	8	22	TMDS CLOCK- SHIELD
13	13	NC	CEC
14	14	NC	RESERVED
19	19	16	HOT PLUG DETECT
17	17	15	DDC/CED GROUND
15	15	6	SCL
16	16	7	SDA
18	18	14	+5V POWER
SHELL		SHELL	DRAIN

NOTES:


- CABLE: [(30AWG*7/0.10mm*1P+DAM) *5+30AWG*4C]+ADB
PVC OUTERJACKET BLACK, OD: 6.0+ 0.20mm
HIGH SPEED HDMI CABLE W/ ETHERNET, UL LIST
- CONNECTORS:
HDMI A/M, CONTACT:3U" GOLD PLT, SHELL 1U" GOLD PLT,
INSULATION: BLACK
DVI-D (24+1)P PCB
- ELECTRICAL TEST:
(1)- 100% OPEN SHORT & MISS WIRE TEST
(2)- INSULATION: DC 300V/0.01s 10M OHM MIN.
(3)- CONDUCTOR RESISTANCE: 2 OHM

PACKAGING:

COMPONENT SHALL BE PACKAGED IN ACCORDANCE
WITH L-COM SPEC PS-0031

REGULATORY COMPLIANCE:
CE 2011/65/EU(RoHS DIRECTIVE)



UNLESS OTHERWISE SPECIFIED, DIMENSIONS ARE IN INCHES [mm] OVERALL CABLE LENGTH TOLERANCE: ≤12 [305] = +1 [25] / -0 >12 [305] ≤60 [1524] = +2 [51] / -0 >60 [1524] ≤120 [3048] = +4 [102] / -0 >120 [3048] ≤300 [7620] = +6 [152] / -0 >300 [7620] = +5% / -0% ALL OTHER DIMENSIONAL TOLERANCES: X = ± .2 [5.08] XX = ± .02 [51] XXX = ±.005 [13]	APPROVALS	DATE	<div>50 HIGH STREET NORTH ANDOVER, MA 01845</div>			
	DRAWN BY B.PUCHASKI	04/19/17				
	CHECKED BY B.ZHANG	04/27/17	CATEGORY	AUDIO/VIDEO		
	APPROVED BY B.GATES	04/21/17				
CONFIGURATION DETAILS OF UNDIMENSIONED FEATURES MAY VARY	PRODUCT DESCRIPTION			HDMI A MALE TO DVI DONGLE		
	COLOR VARIATIONS MAY OCCUR	SIZE	FSCM NO.	DWG. NO.	REV.	
A		43321	HDHKC950PBB	B		
SCALE: NONE						
CAD FILE: HDHKC950PBB.SLDDRW						
SHEET 1 OF 1						