

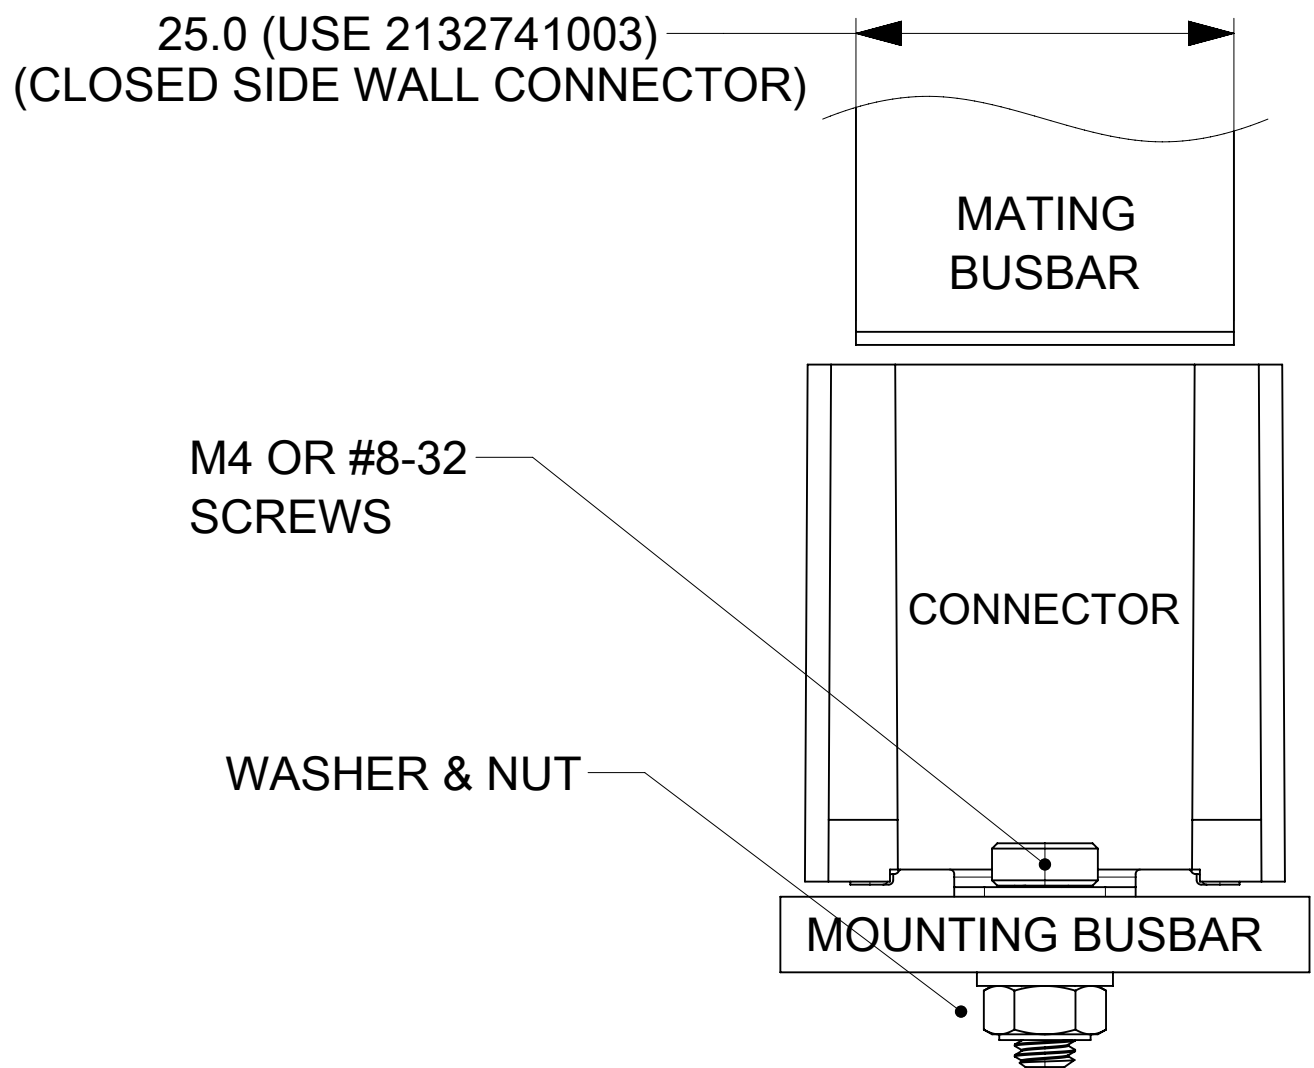
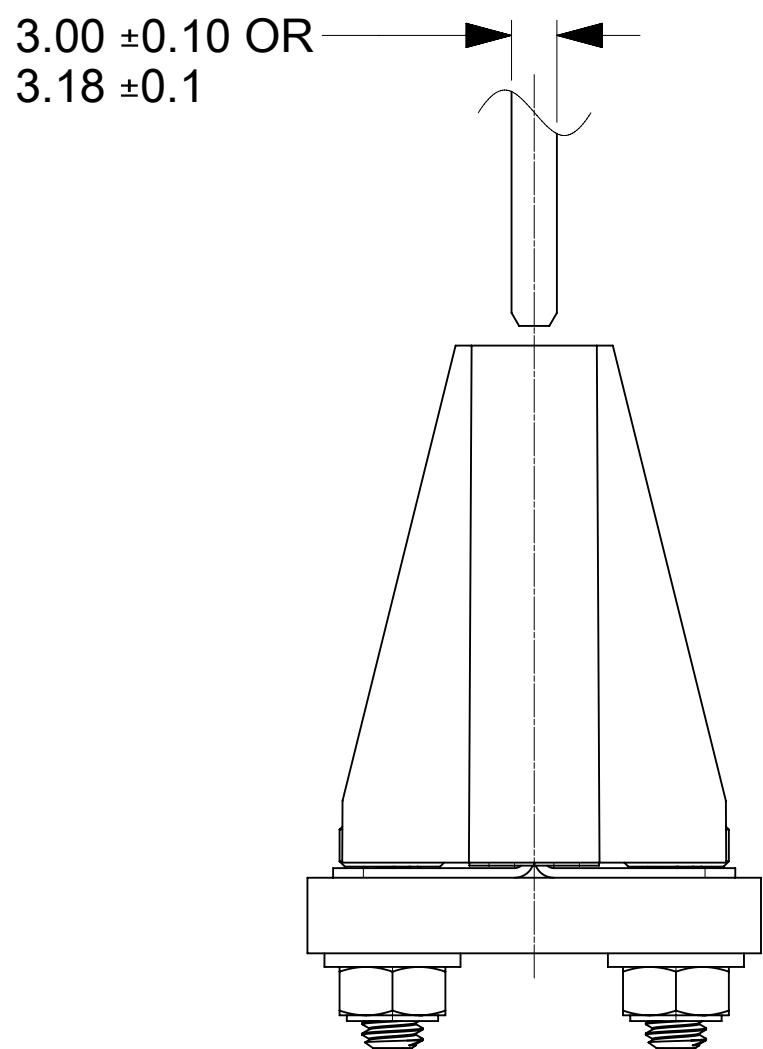
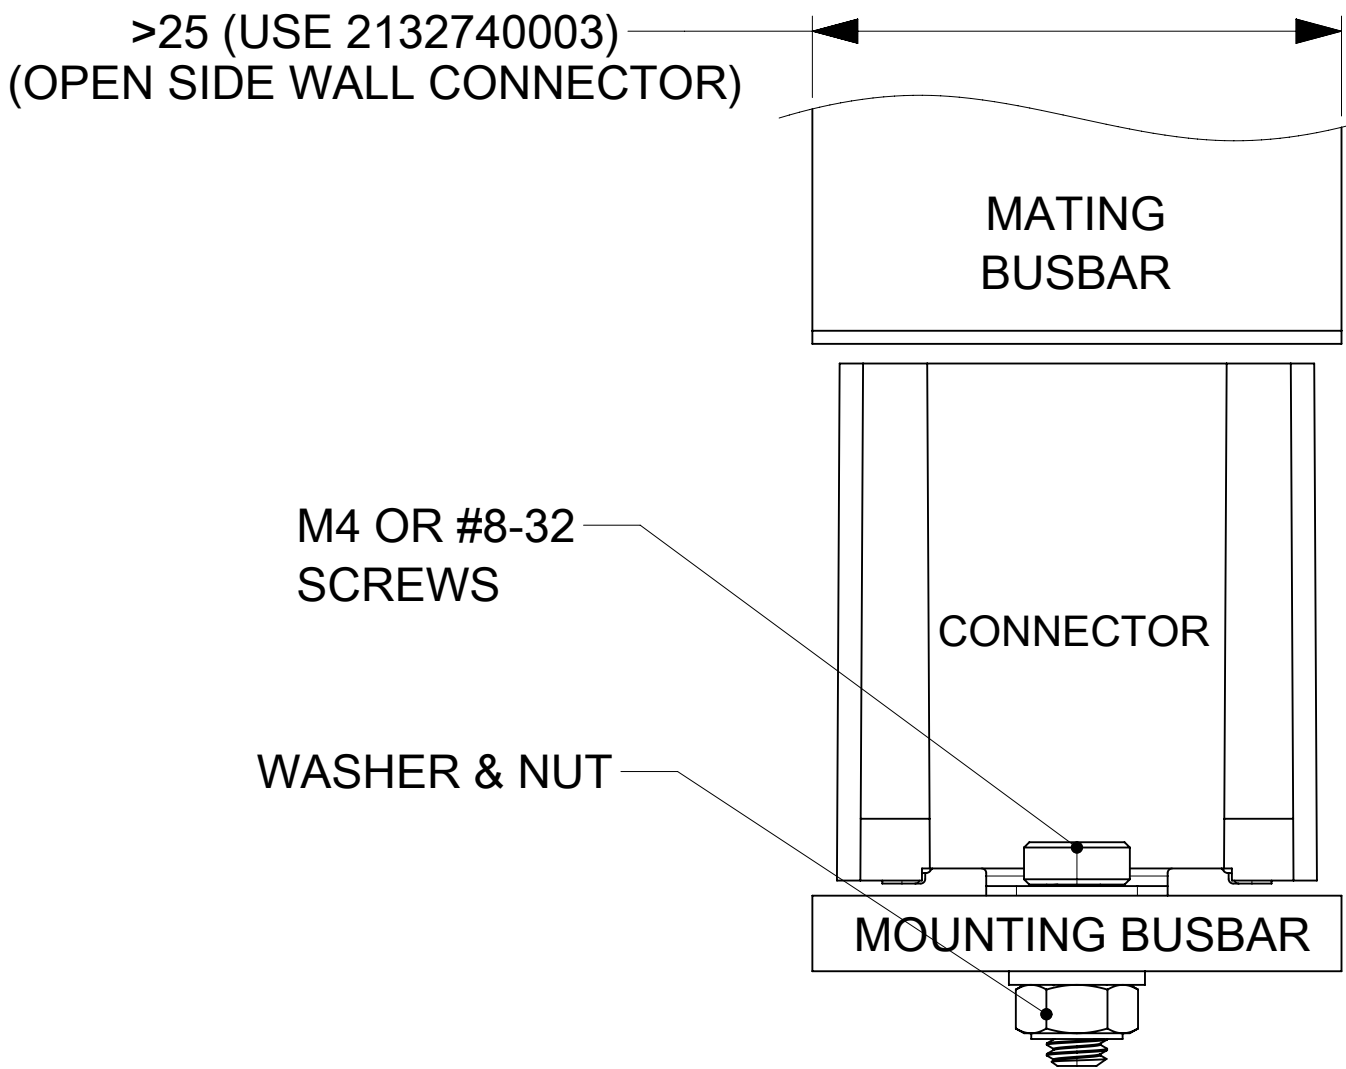
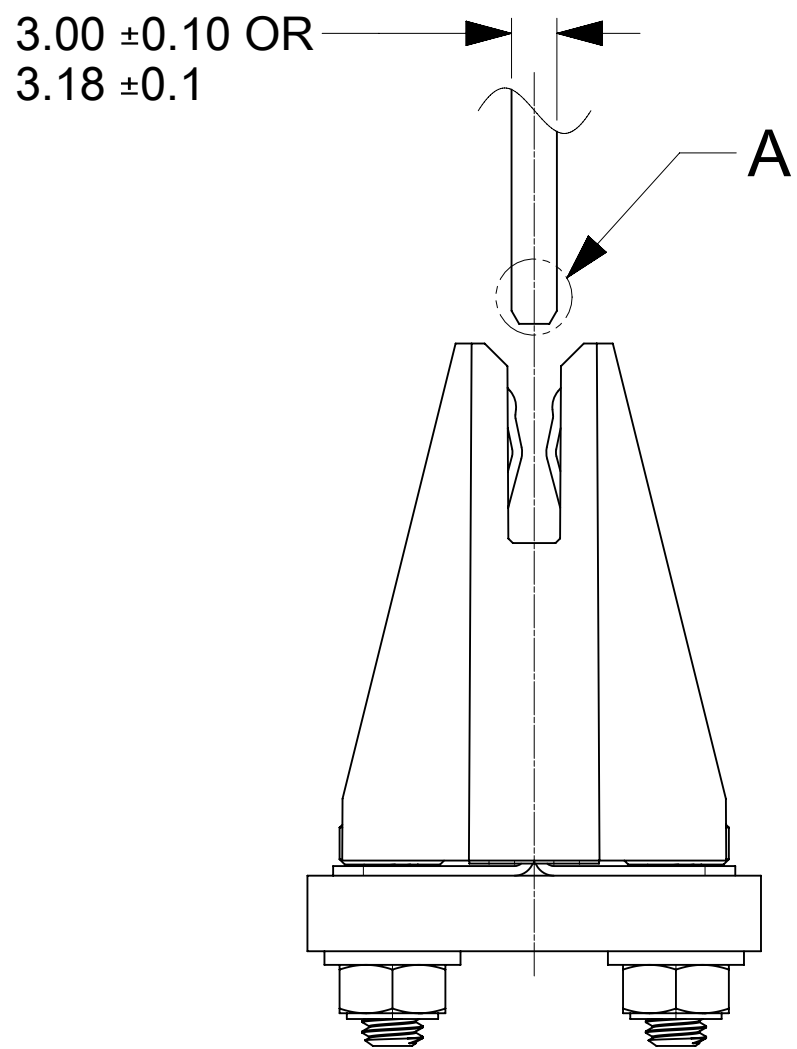





PART NUMBER	DESCRIPTION	NOTE
2132740004	OPEN SIDE WALL	
2132741004	CLOSED SIDE WALL	

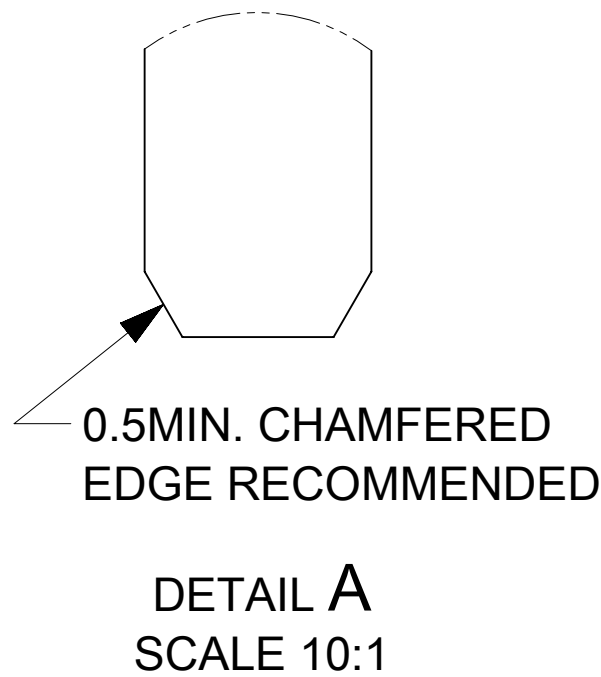


BUSBARS, SCREWS, WASHER AND NUTS
IN THESE VIEWS ARE SHOWN FOR REFERENCE

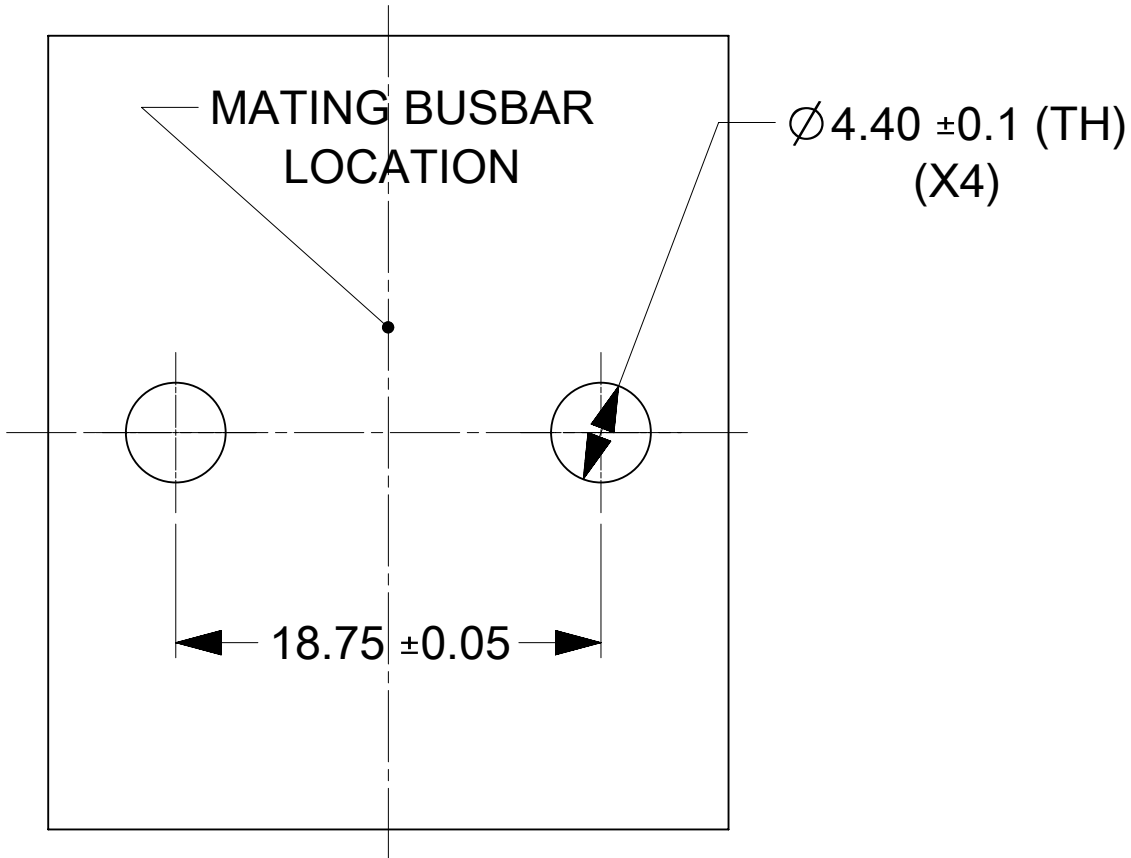

- NOTES:
- MATERIALS:
 - HOUSING BODY: POLYMER, UL94V-0, BLACK.
 - TERMINALS: COPPER ALLOY.
 - RIVET/CLIP: COPPER ALLOY.
 - PLATING:
 - CONTACT AREAS: 3.18 MICRON MIN. SILVER, OVER 1.27 MICRON MIN. NICKEL.
 - TAB AREAS: 3.18 MICRON MIN. TIN OVER 1.27 MICRON MIN. NICKEL.
 - REST: 1.27 MICRON MIN. NICKEL.
 - LUBRICATION: LUBED IN CONTACT AREA.
 - REFERENCE DOCUMENT: 2132740001-PS, 2132740001-AS
 - MODULE ASSEMBLY IS RoHS COMPLIANT.
 - FINAL ASSEMBLY TO BE PACKAGED AND LABELED PER PACKAGING KIT DRAWING NUMBER 2132740003-PK.

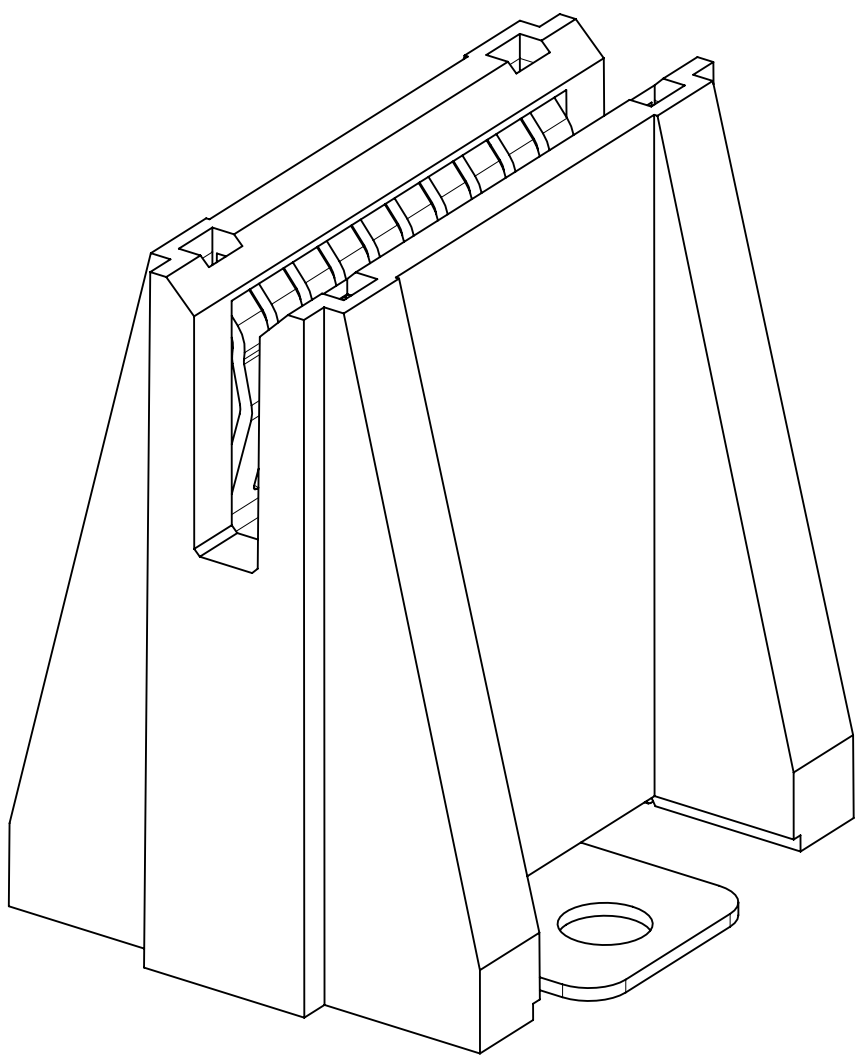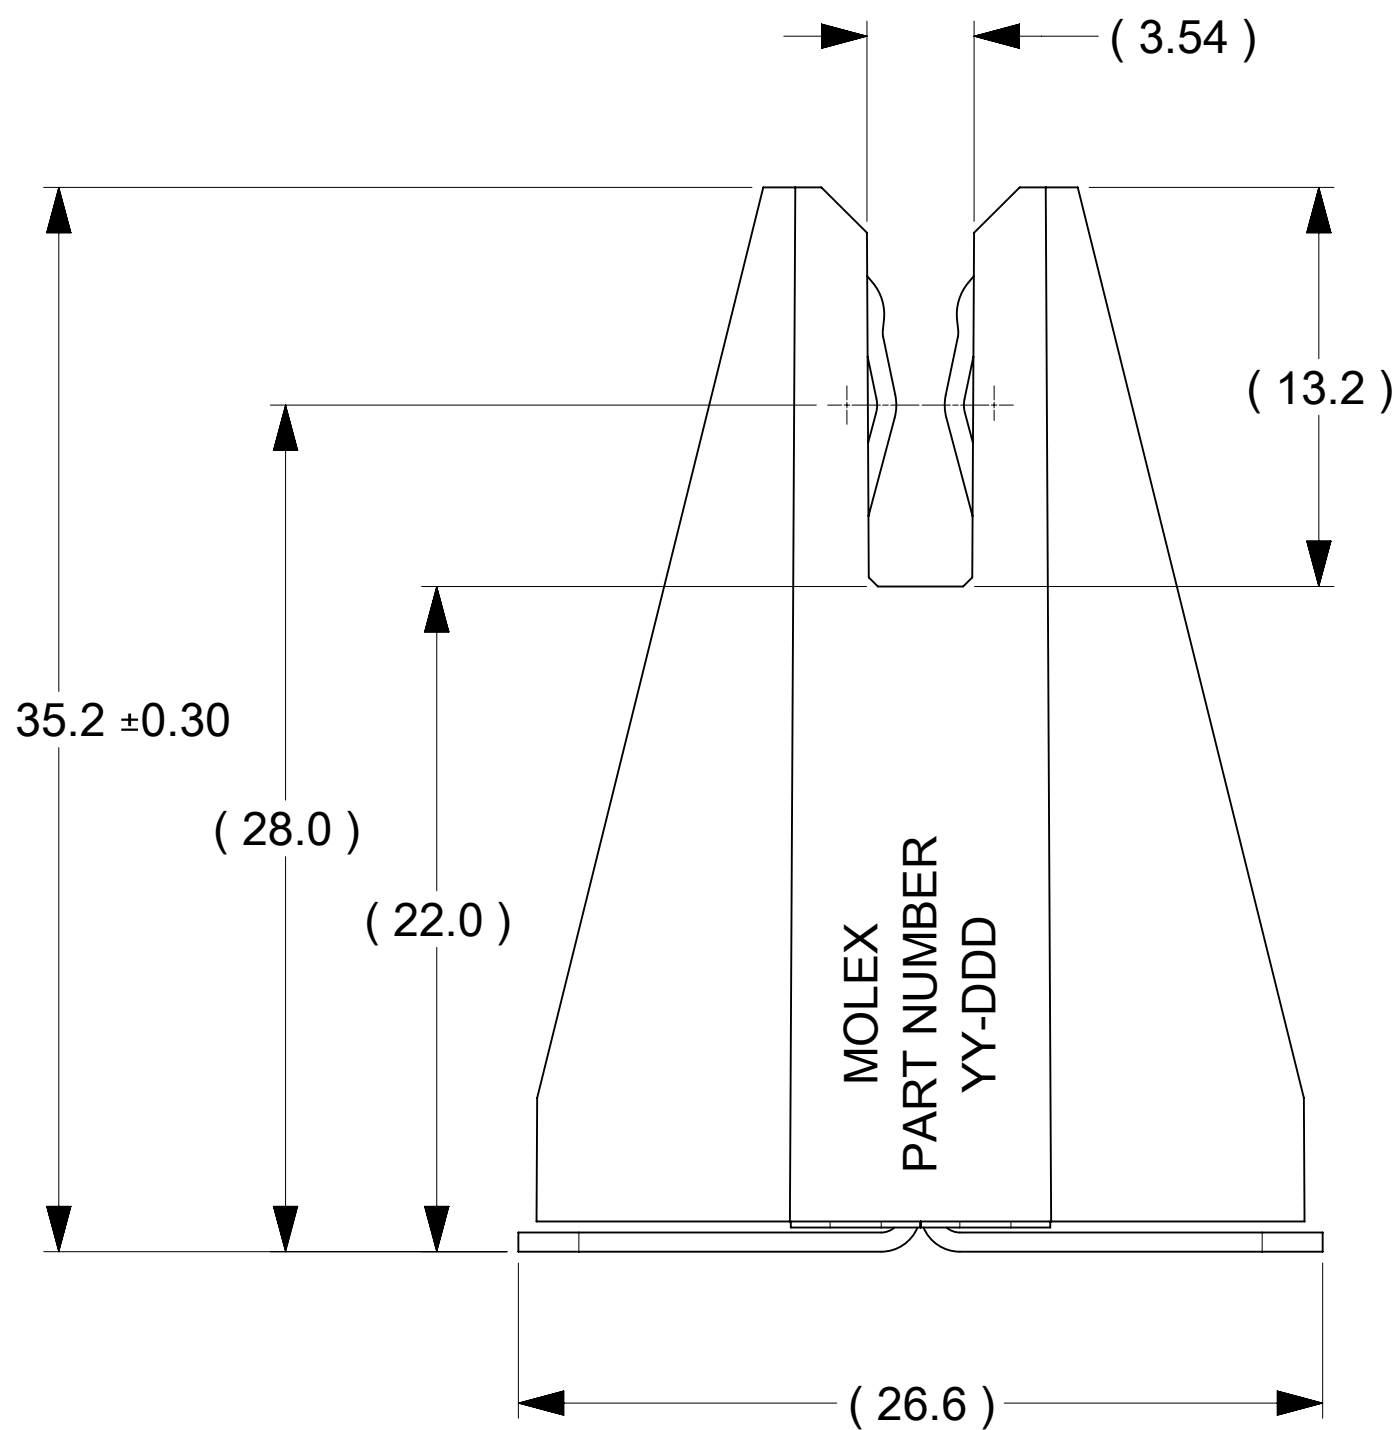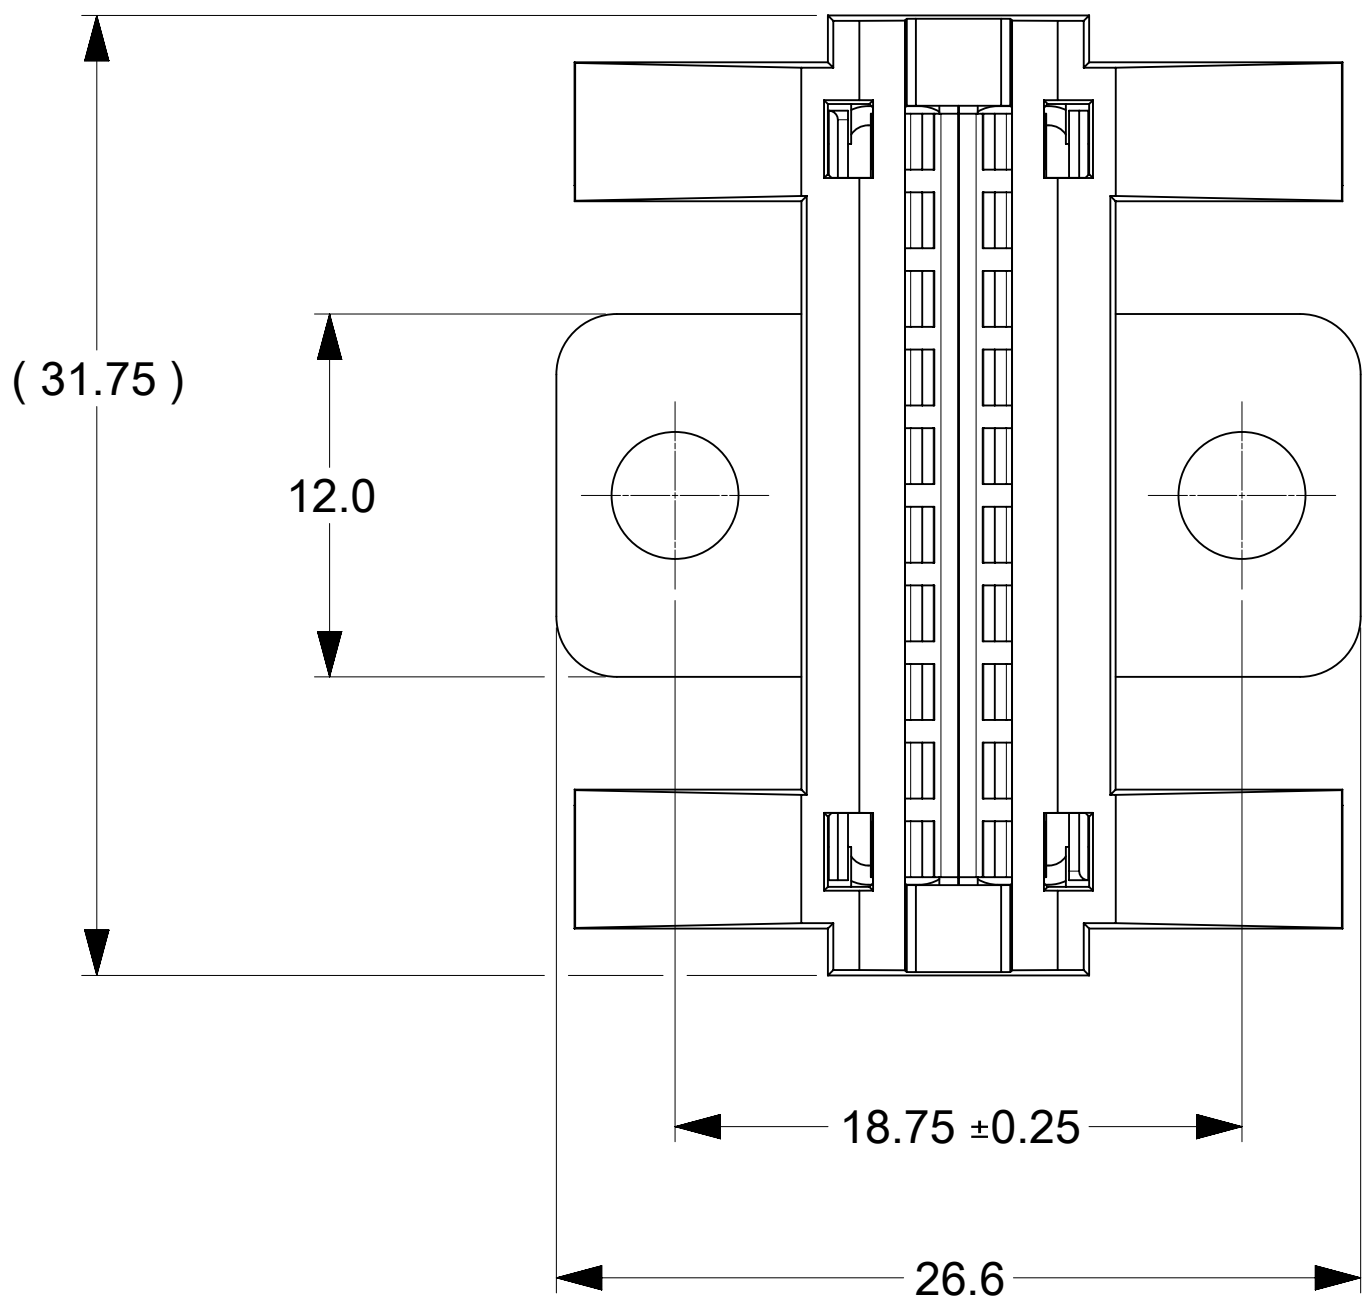

PART NUMBER: 2132740004
(OPEN SIDE WALLS)

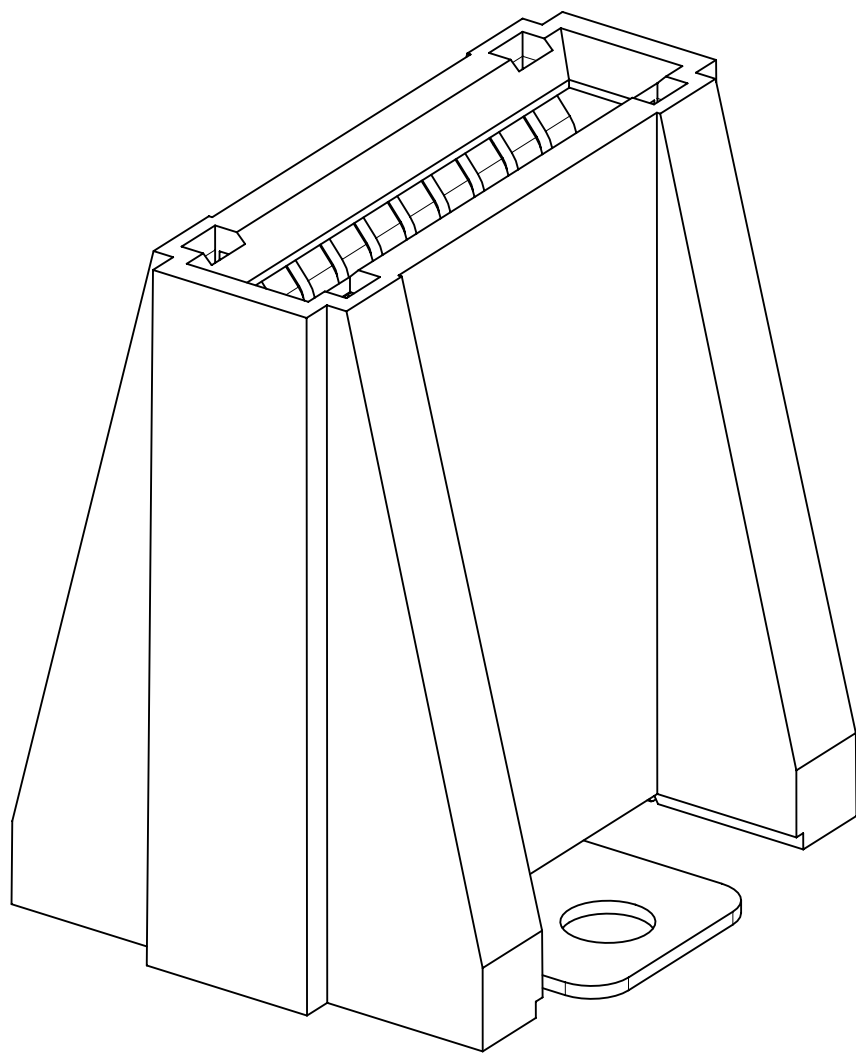

PART NUMBER: 2132741004
(CLOSED SIDE WALLS)

RECOMMENDED BUSBAR LAYOUT

FUNCTIONAL SYMBOLS	THIS DRAWING CONTAINS INFORMATION THAT IS PROPRIETARY TO MOLEX ELECTRONIC TECHNOLOGIES, LLC AND SHOULD NOT BE USED WITHOUT WRITTEN PERMISSION											
DIVISIONAL SYMBOLS	DIMENSION UNITS		SCALE		CURRENT REV DESC:			molex				
	mm		3:1									
	GENERAL TOLERANCES (UNLESS SPECIFIED)					EC NO: 690682 DRWN: TOMLU 2022/01/03 CHK'D: BPISZCZOR 2022/01/04 APPR: BPISZCZOR 2022/01/04 INITIAL REVISION: DRWN: TOMLU 2021/04/07 APPR: BPISZCZOR 2021/12/21			POWER PLANE BBC 10C VERTICAL_SINGLE HOLE			
	ANGULAR TOL ± °											
	4 PLACES		±		PRODUCT CUSTOMER DRAWING							
	3 PLACES		±		DOCUMENT NUMBER				DOC TYPE	DOC PART	REVISION	
	2 PLACES		± 0.15		2132740004-SD				PSD	000	A1	
	1 PLACE		± 0.25		MATERIAL NUMBER		CUSTOMER			SHEET NUMBER		
0 PLACES		±		SEE CHART		1 OF 1						
DRAFT WHERE APPLICABLE MUST REMAIN WITHIN DIMENSIONS					THIRD ANGLE PROJECTION		DRAWING	SERIES				
							D-SIZE	213274				

DOCUMENT STATUS	P1	RELEASE DATE	2022/01/07	20:22:01
-----------------	----	--------------	------------	----------